


DESIGN, PLANNING AND DEVELOPMENT

SUITE 700
101 CONVENTION CENTER DR.
LAS VEGAS, NV

www.designservicesplus.com

SUBHAS MAZUMDAR, AIA, NCARB
Design Services Plus, Inc.
101 Convention Center Dr. Suite #700
Las Vegas, NV

TEL: (302) 897 2501

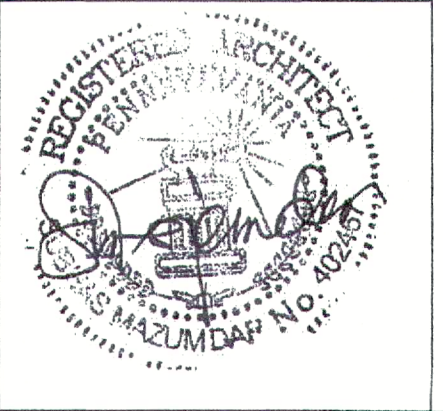

PROFESSIONAL CERTIFICATION

I CERTIFY THAT THESE DOCUMENTS WERE PREPARED
OR APPROVED BY ME, AND THAT I AM A DULY
LICENSED ARCHITECT UNDER THE LAWS OF THE
STATE OF PENNSYLVANIA:

LICENSE NO. 402457 EXPIRING ON 2/17/2018

[illegible]



Manny Mathai
HEALTHCARE FACILITIES
NURSING HOME (PHASE 2)

3RD, 4TH & 5TH FLOOR
SIDE A ELECTRICAL
LIGHTING PLAN


Project number	SK-2015-006
Date	10/14/2015
Drawn by	Author
Checked by	Checker

E-320

Scale $1/8" = 1'-0"$

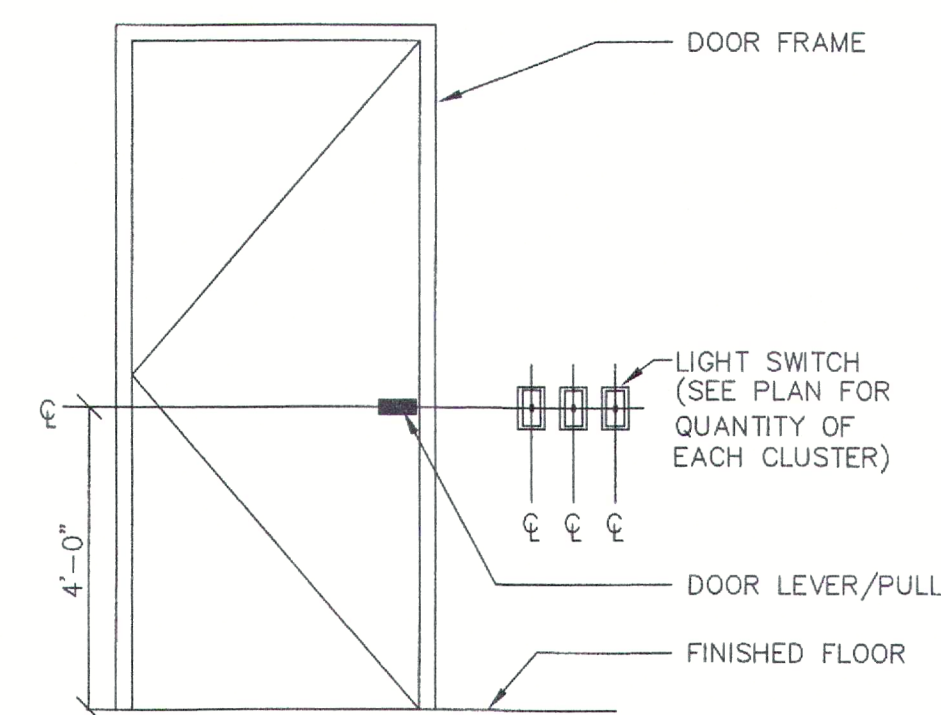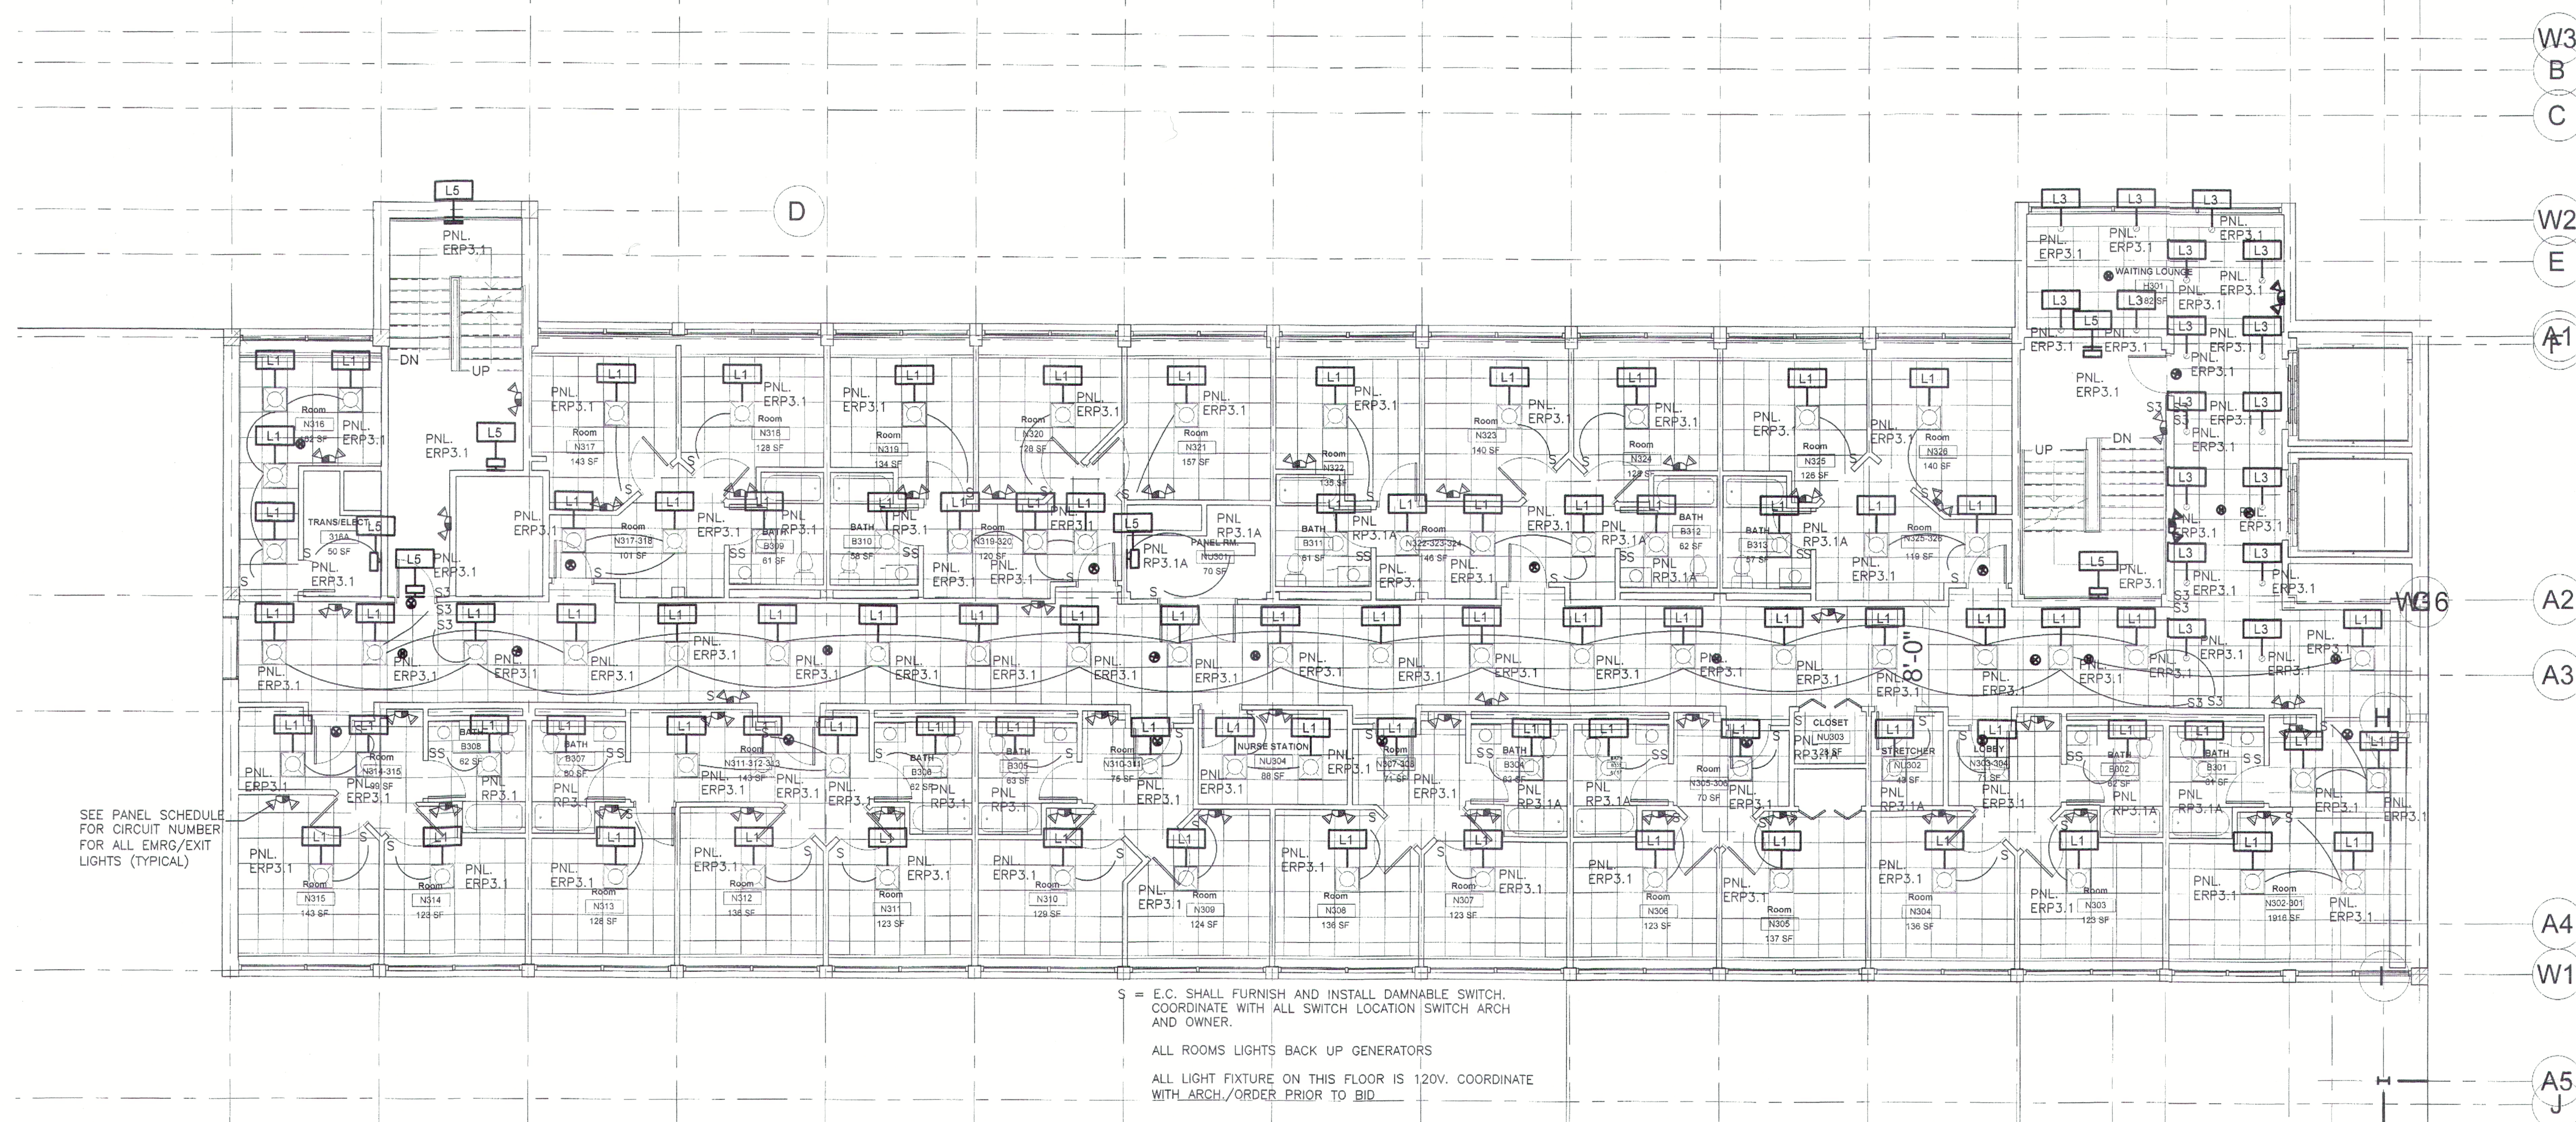


TYPICAL LOCATION FOR LIGHT SWITCHES.
NTS

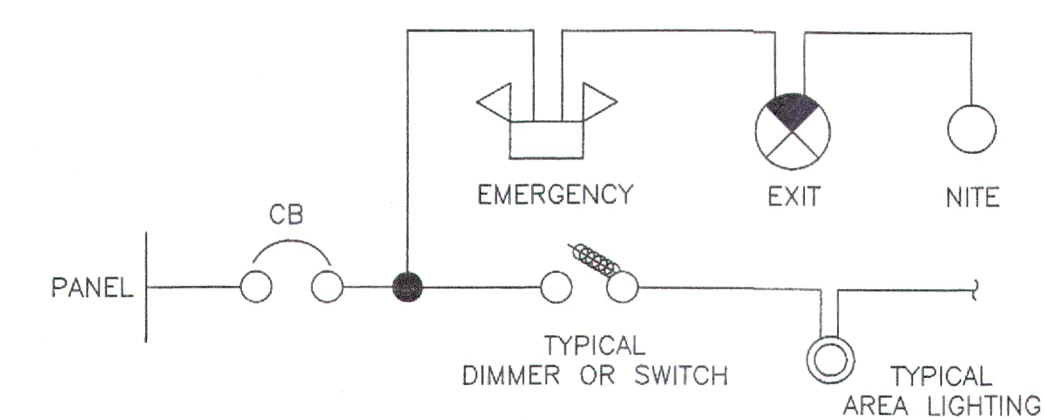

TYP. EMERGENCY LIGHT WIRING DIA.

1 3RD, 4TH & 5TH FLOOR SIDE A LIGHTING PLAN

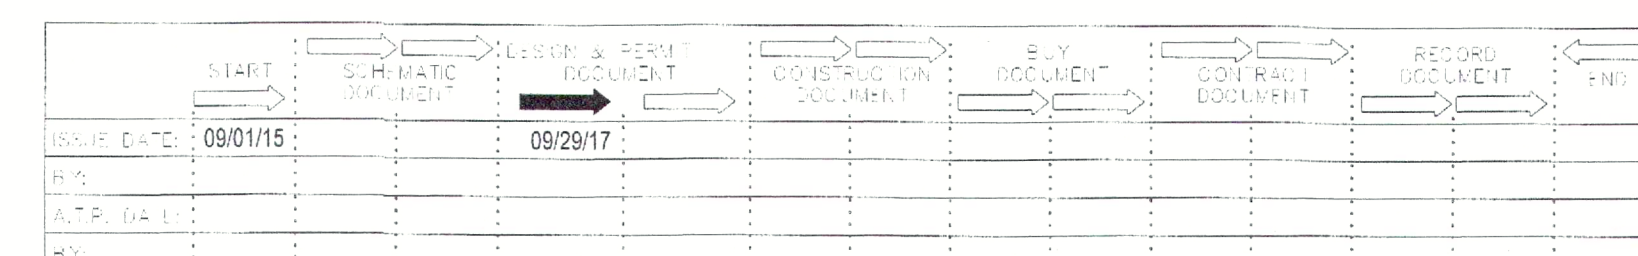

ISSN 0950-0804