


DESIGN, PLANNING
AND DEVELOPMENT

SUITE 700
101 CONVENTION CENTER DR.
LAS VEGAS, NV

www.designservicesplus.com

SUBHAS MAZUMDAR, AIA, NCARB
Design Services Plus, Inc.
101 Convention Center Dr. Suite #700
Las Vegas, NV

TEL: (302) 897 2501

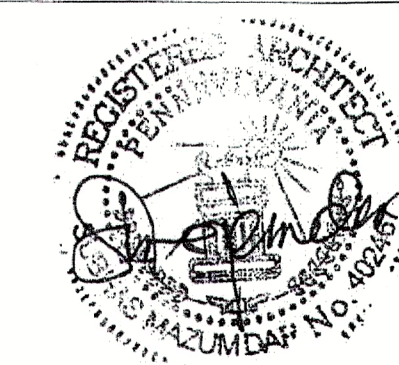

PROFESSIONAL CERTIFICATION

I CERTIFY THAT THESE DOCUMENTS WERE PREPARED
OR APPROVED BY ME, AND THAT I AM A DULY
LICENSED ARCHITECT UNDER THE LAWS OF THE
STATE OF PENNSYLVANIA:

LICENSE NO. 402457 EXPIRING ON 2/17/2018

[illegible]

Manny Mathai
HEALTHCARE FACILITIES
NURSING HOME (PHASE 2)

1ST
FLOOR NURSING
HOME SIDE A
SANITARY/VENT
PIPING PLAN

Project number SK-2015-006


Project Number	SR-2015-000
Date	10/14/2015

Drawn by ASitro


Checked by	Checker
------------	---------

P-101

Scale 1/8" = 1'-0"

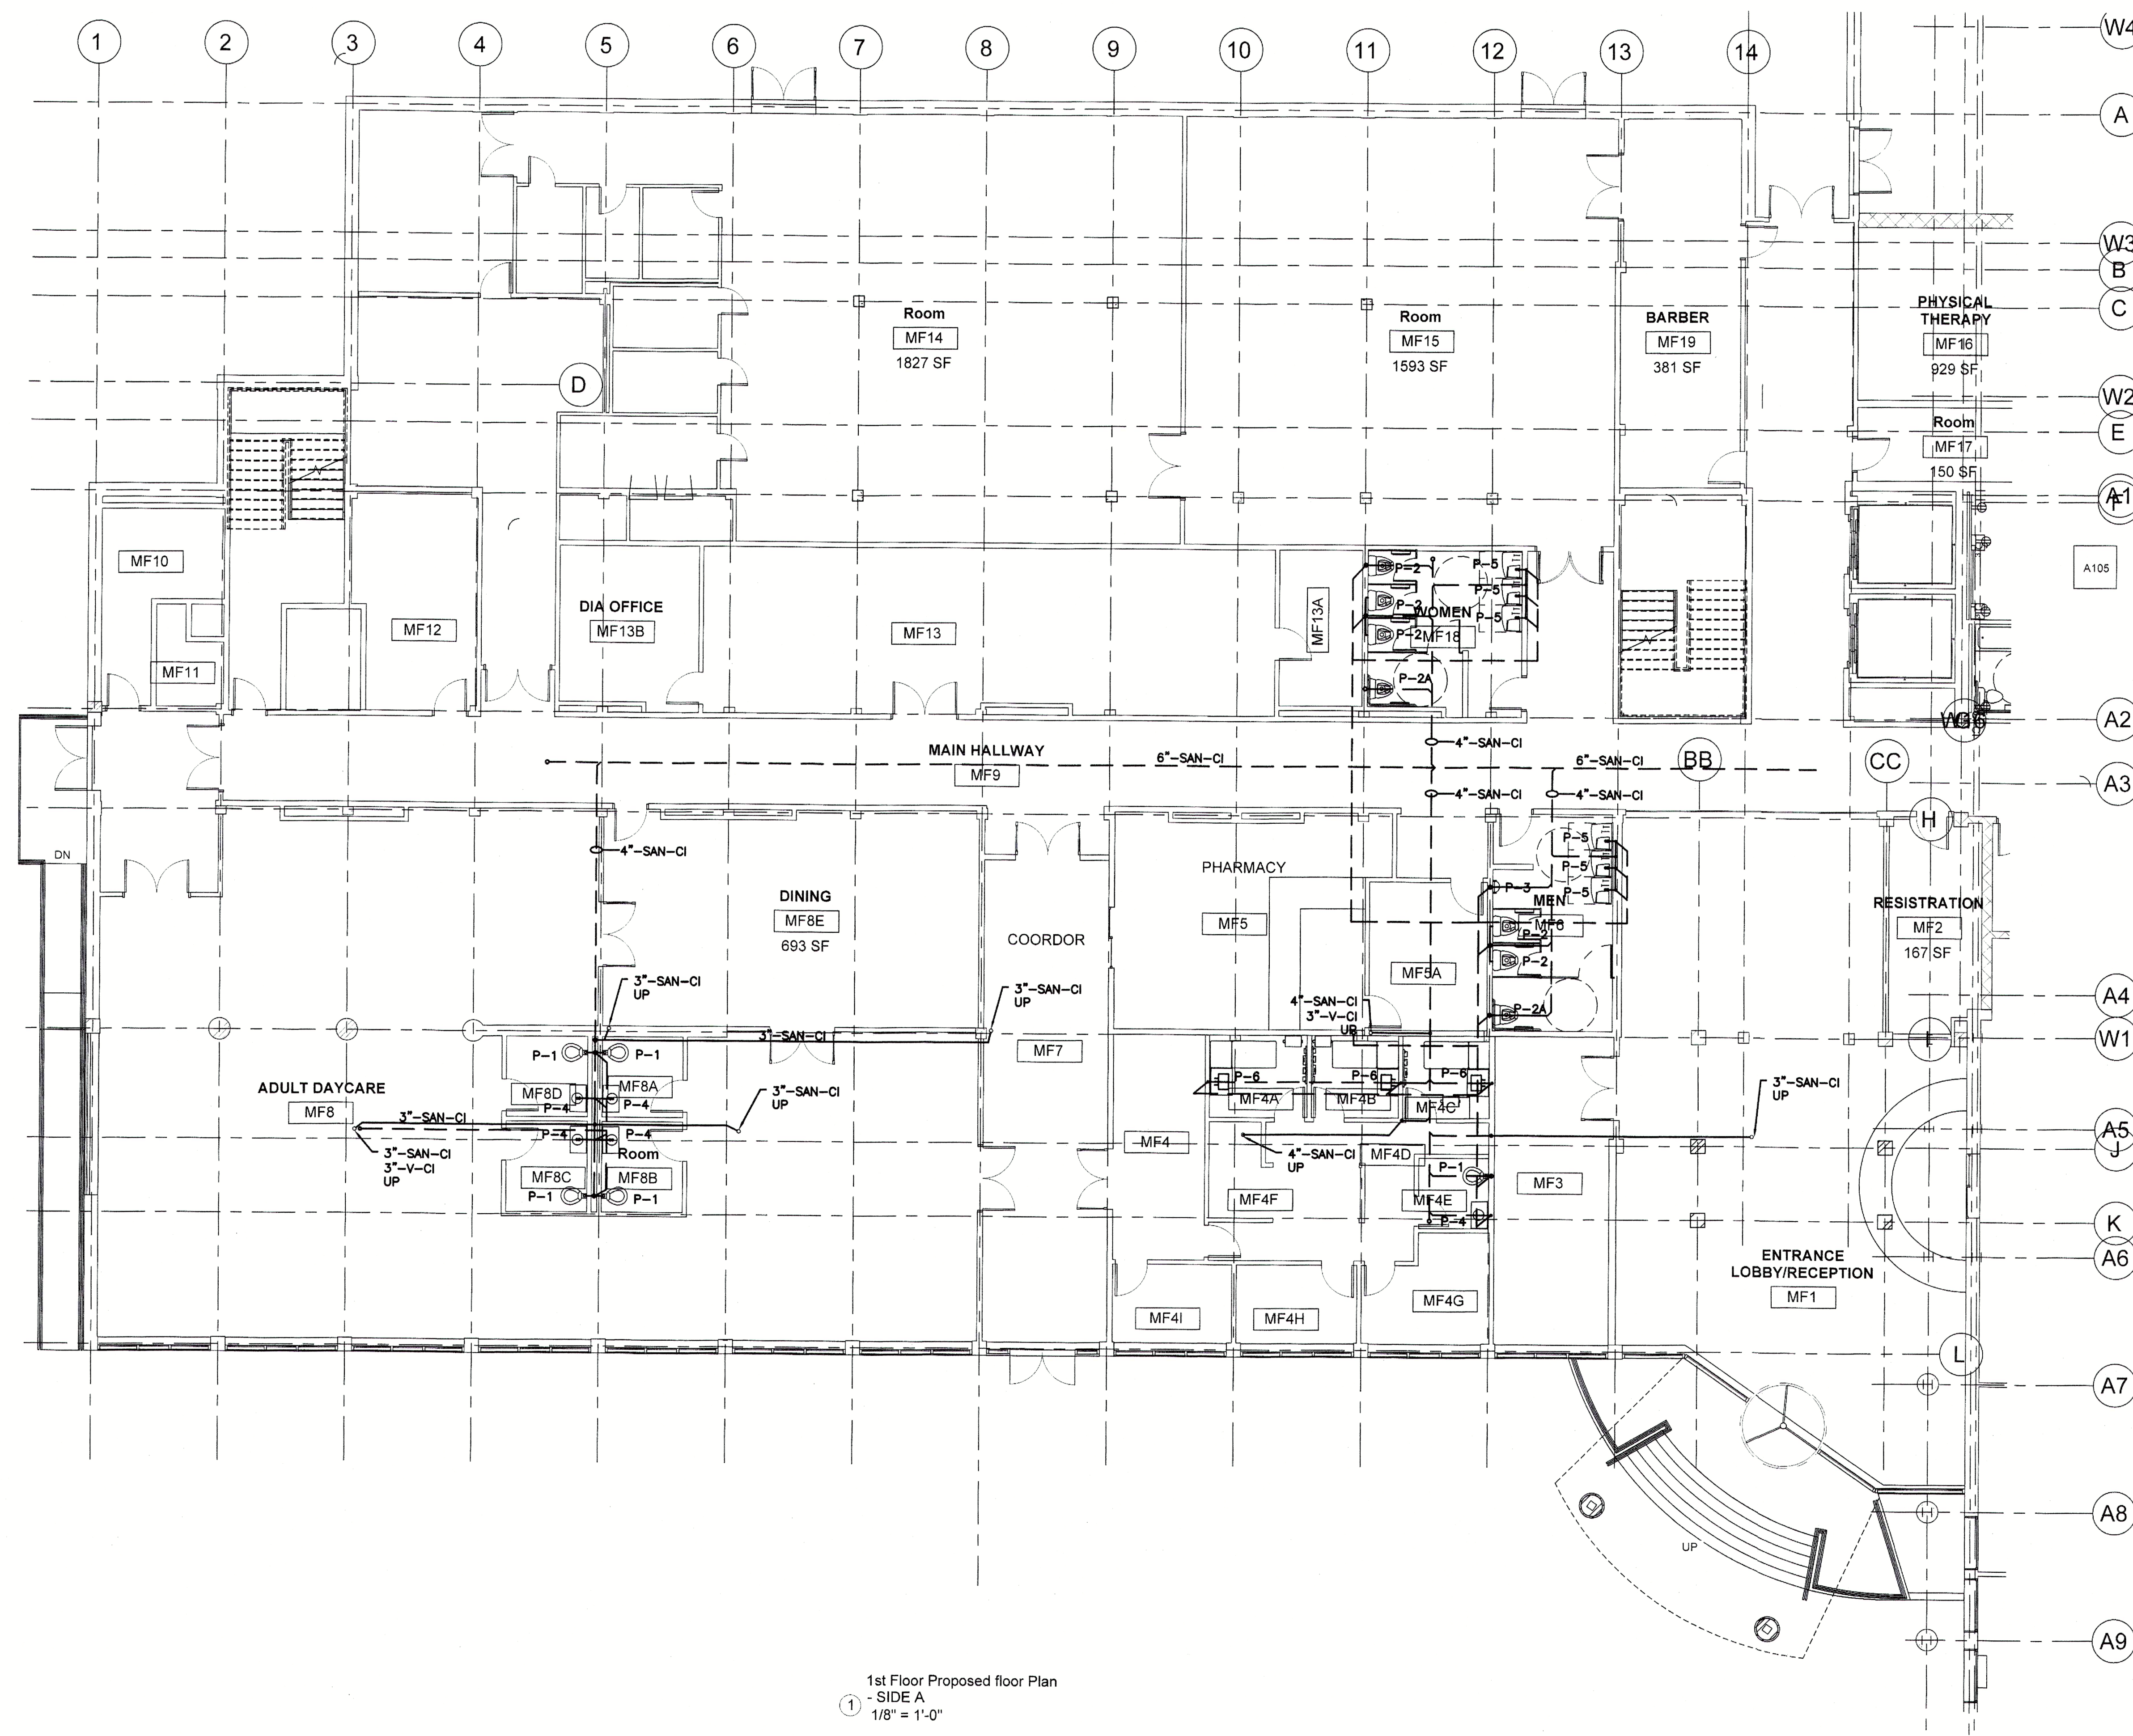

1st Floor Proposed floor Plan
- SIDE A
1/8" = 1'-0"

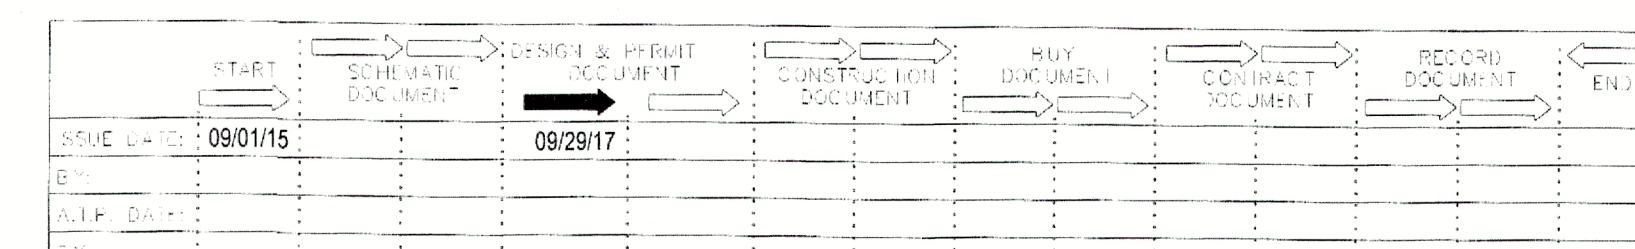

--	--